


- M3000 ELECTRICAL NOTES:
1. CONTROLLER CONDUIT BY OTHERS
  2. CONTROLLER CABLE PROVIDED
  3. MAX 30 CONDUIT FEET FROM MAIN CONTROLLER TO HOUSING
  4. INTERNAL MOTORS ARE ACCESSIBLE THROUGH HOUSING OPENING WHEN UNIT IS DEPLOYED.

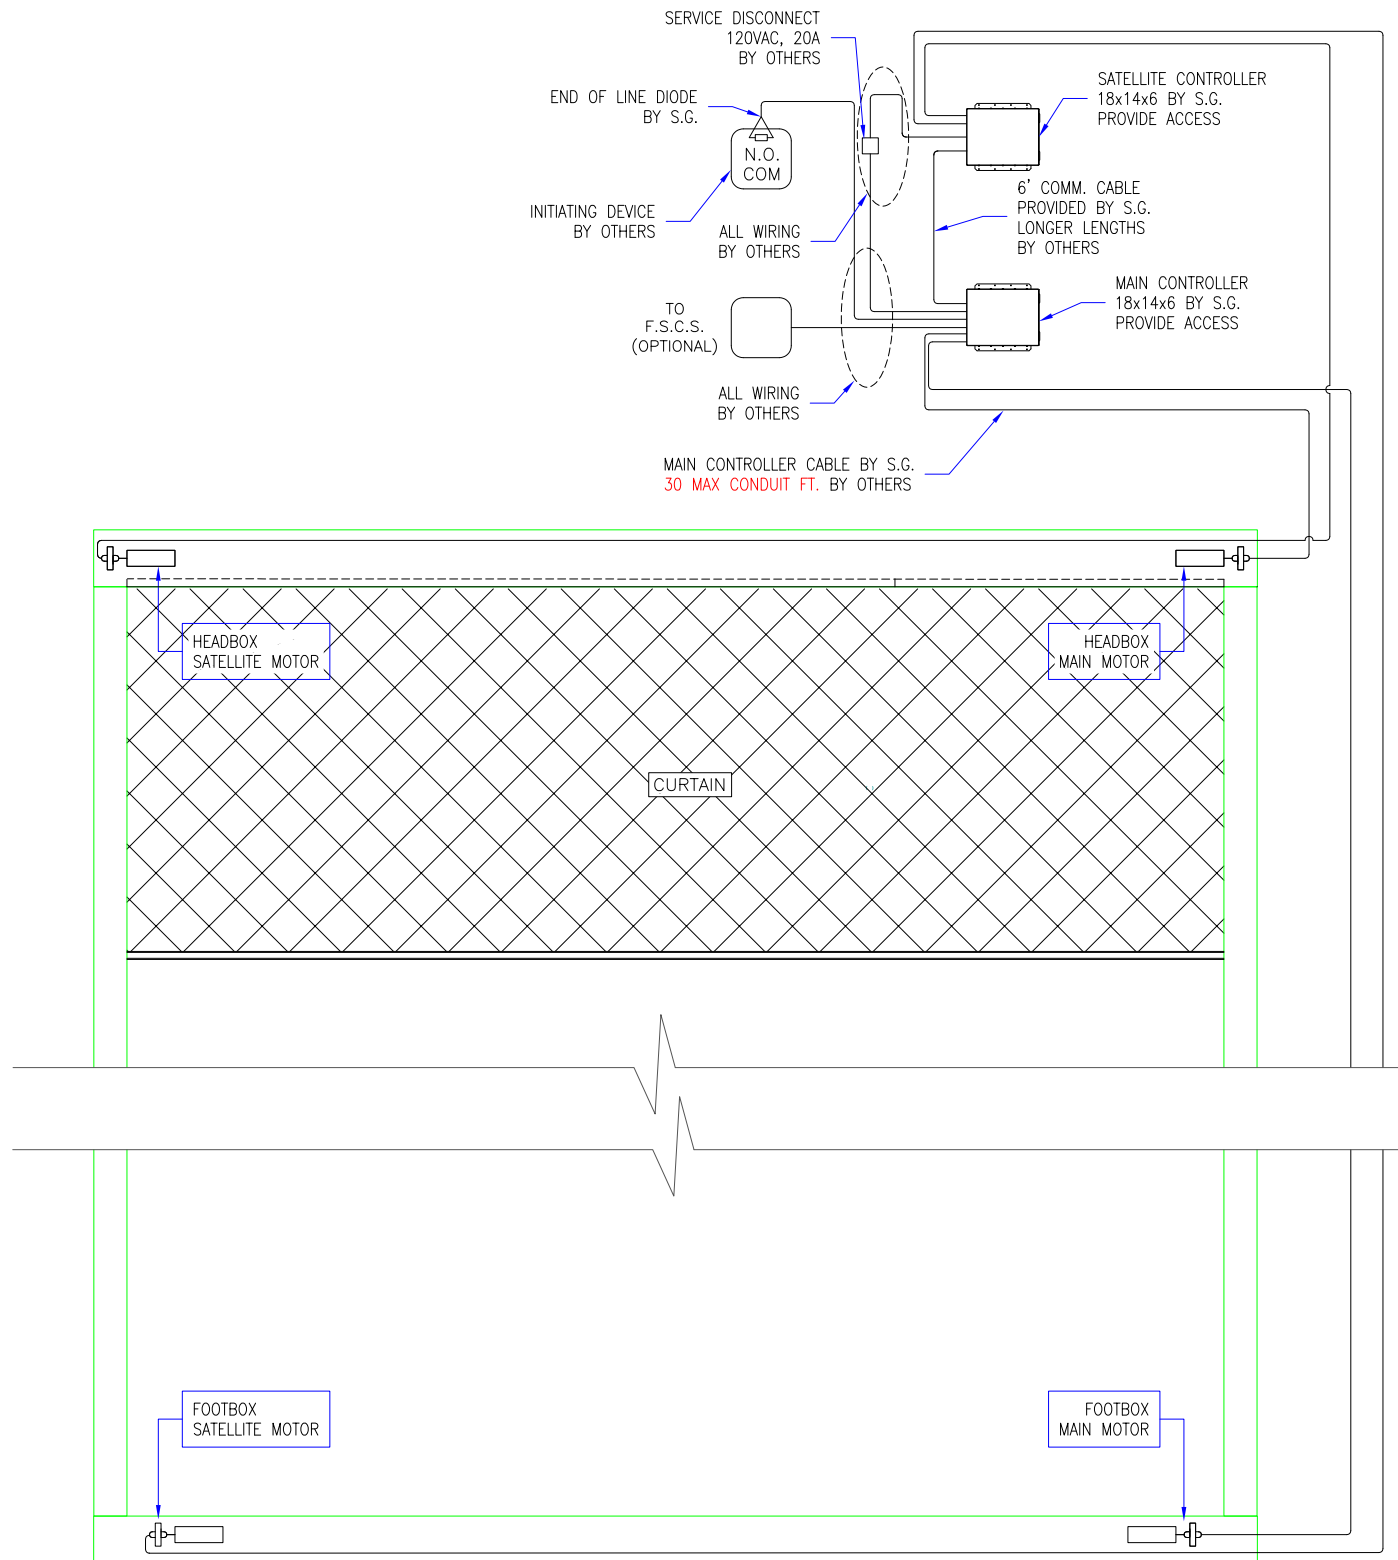

1 M3000 ELECTRICAL DETAILS  
SCALE: 1/4" = 1'-0"

REVISION

REVISION NUMBER	REVISION DATE	REVISION DESCRIPTION
D1	7.28.20	INITIAL RELEASE

QUOTE: ----  
CONFIGURATION: ----  
PROJECT: ----  
DIST.: ----

DESIGN SET: D1	SIZE <b>B</b>
MODEL: M3000	SHEET
SHEET TITLE: M3000 ELECTRICAL DETAILS	1 OF 1
DRAWN: TLM	7.28.2020